



SECOND FLOOR
scale 1/4" = 1'-0"

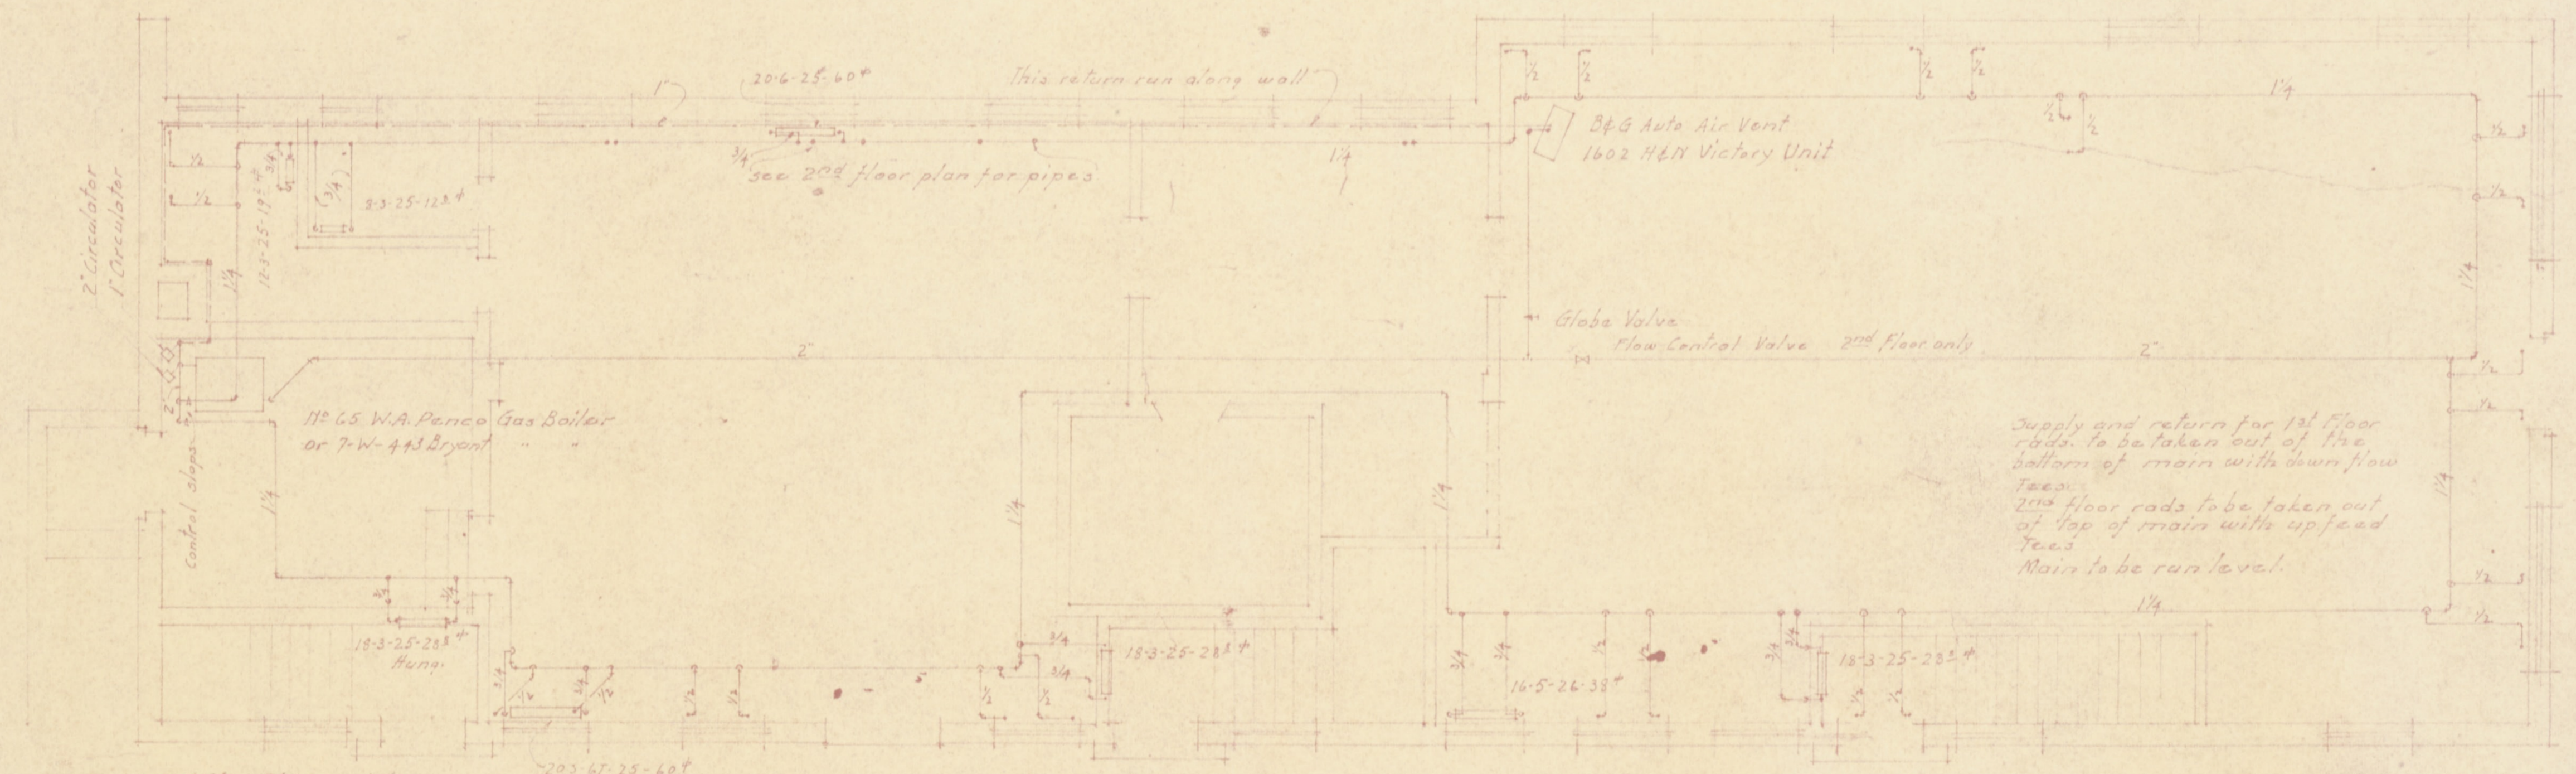

FIRST FLOOR
scale 1/4" = 1'-0"

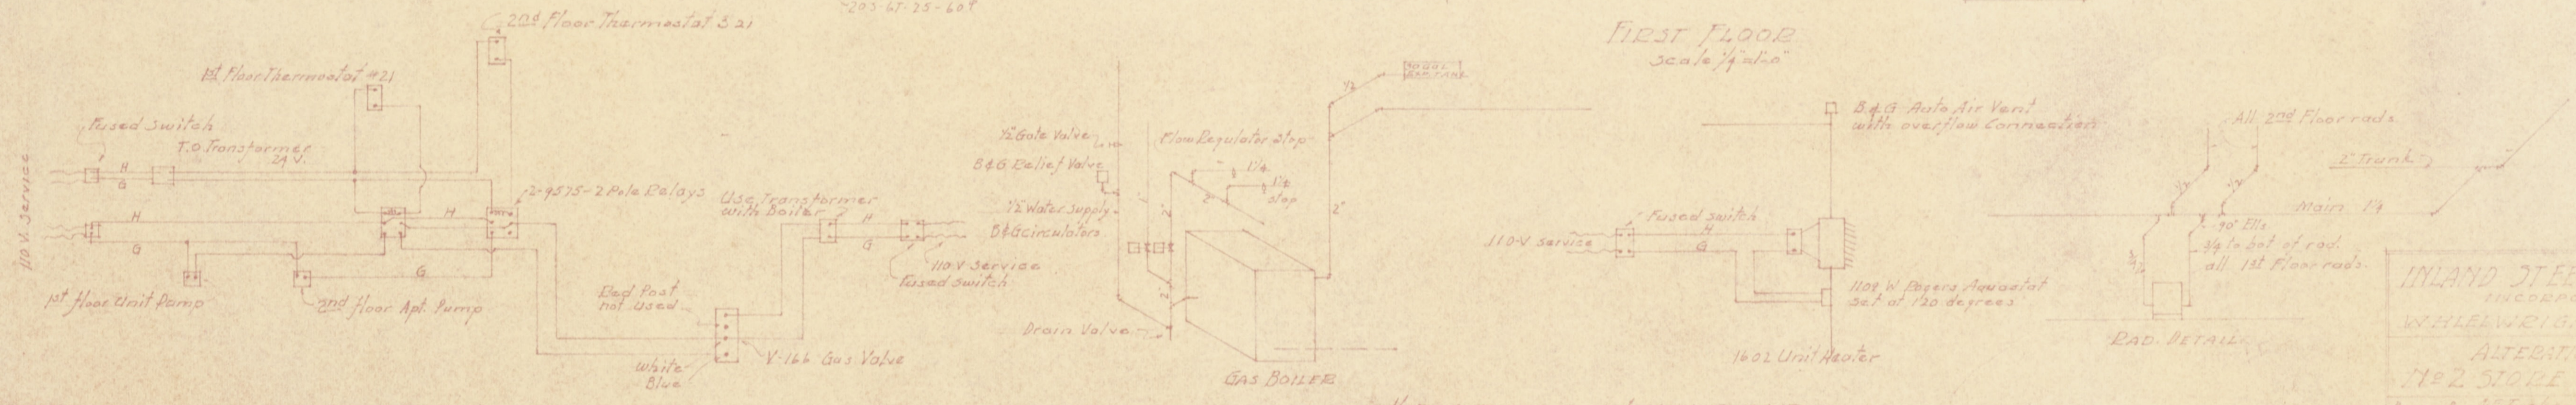

HEATING LAYOUT

Supply and return for 1st floor
rads. to be taken out of fire
bottom of main with down flow
tees.
2nd floor rads to be taken out
of top of main with up feed
tees.
Main to be run level.

INLAND STEEL COMPANY
INCORPORATED
WHEELWRIGHT KENTUCKY
ALTERATIONS TO
#2 STORE BUILDING
Drawn by A. Tucker April 26 1925
Approved
FILE #30-F-112

2886 Wheelwright Collection
Blueprints: 91, Inland Steel